




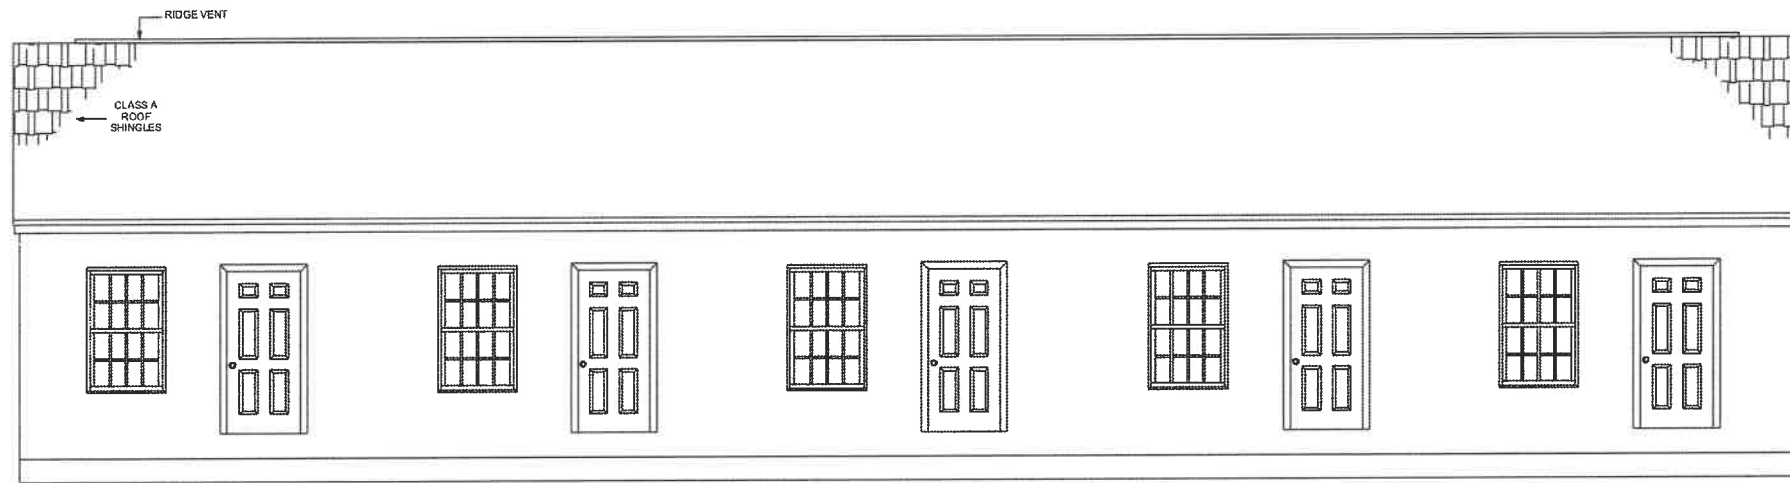


FRONT ELEVATION

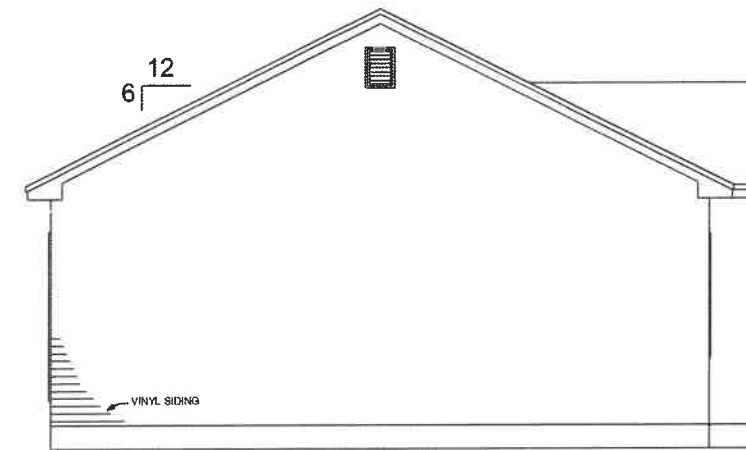

RIGHT ELEVATION

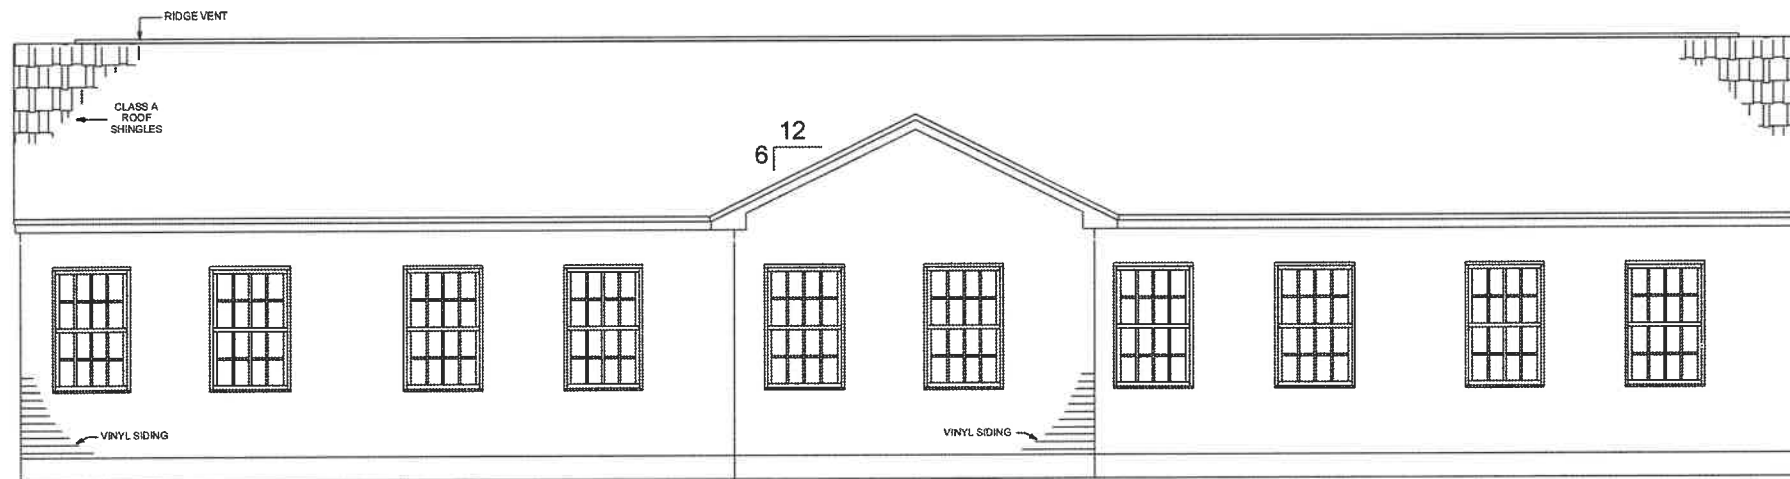

REAR ELEVATION

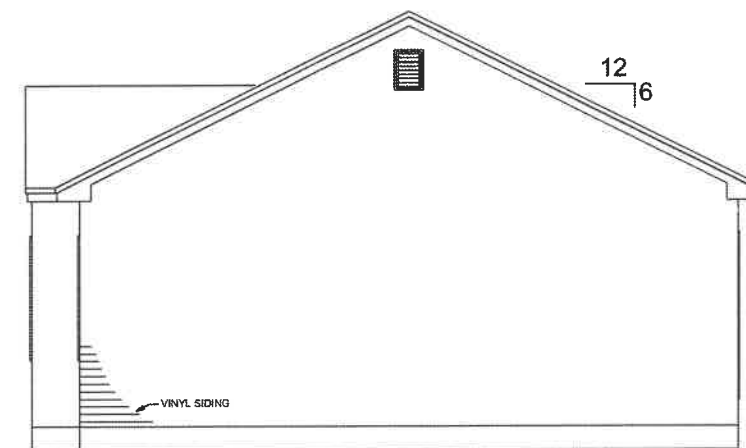


LEFT ELEVATION

PRELIMINARY
NOT FOR
CONSTRUCTION

NOTE:
- ELEVATIONS ARE FOR GRAPHIC
REPRESENTATION ONLY. REFER TO WORK
ORDER FORM FOR DETAILED INFORMATION.
- EXTERIOR STEPS, RAILINGS & LANDINGS
ONSITE BY GC/CSL.

BUNDLES OF SHINGLES: xx
BUNDLES OF RIDGE CAPS: xx

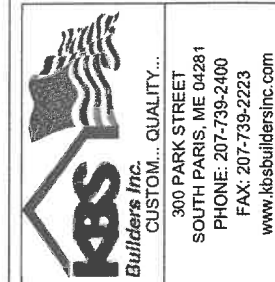


JOB NAME	BUILDER:		PERMIT REV#
	Northern Constructors		
1 Bedrm Building Type	24 Smith Corner Rd		DATE:
	Newton, NH 03858		
Puzzle Lane	PERMIT REV#		DATE:
	Newton, NH 03858		
REV#/DATE:	PERMIT REV#		DATE:
REV#/DATE:	PERMIT REV#		
REV#/DATE:	PERMIT REV#		DATE:
REV#/DATE:	PERMIT REV#		

NOTES:
Ranch
50# GSL / 122 MPH (Vuit) WIND
HARVEY WINDOWS
8'-0" CLG HGT

FILE: Q-22-0015-JM	ELEVATIONS
SERIAL #: KBS-	
DATE: 2/25/2022	
OWN BY: SLP	

SHEET #	P2
SCALE:	NONE

PRELIMINARY
NOT FOR
CONSTRUCTION

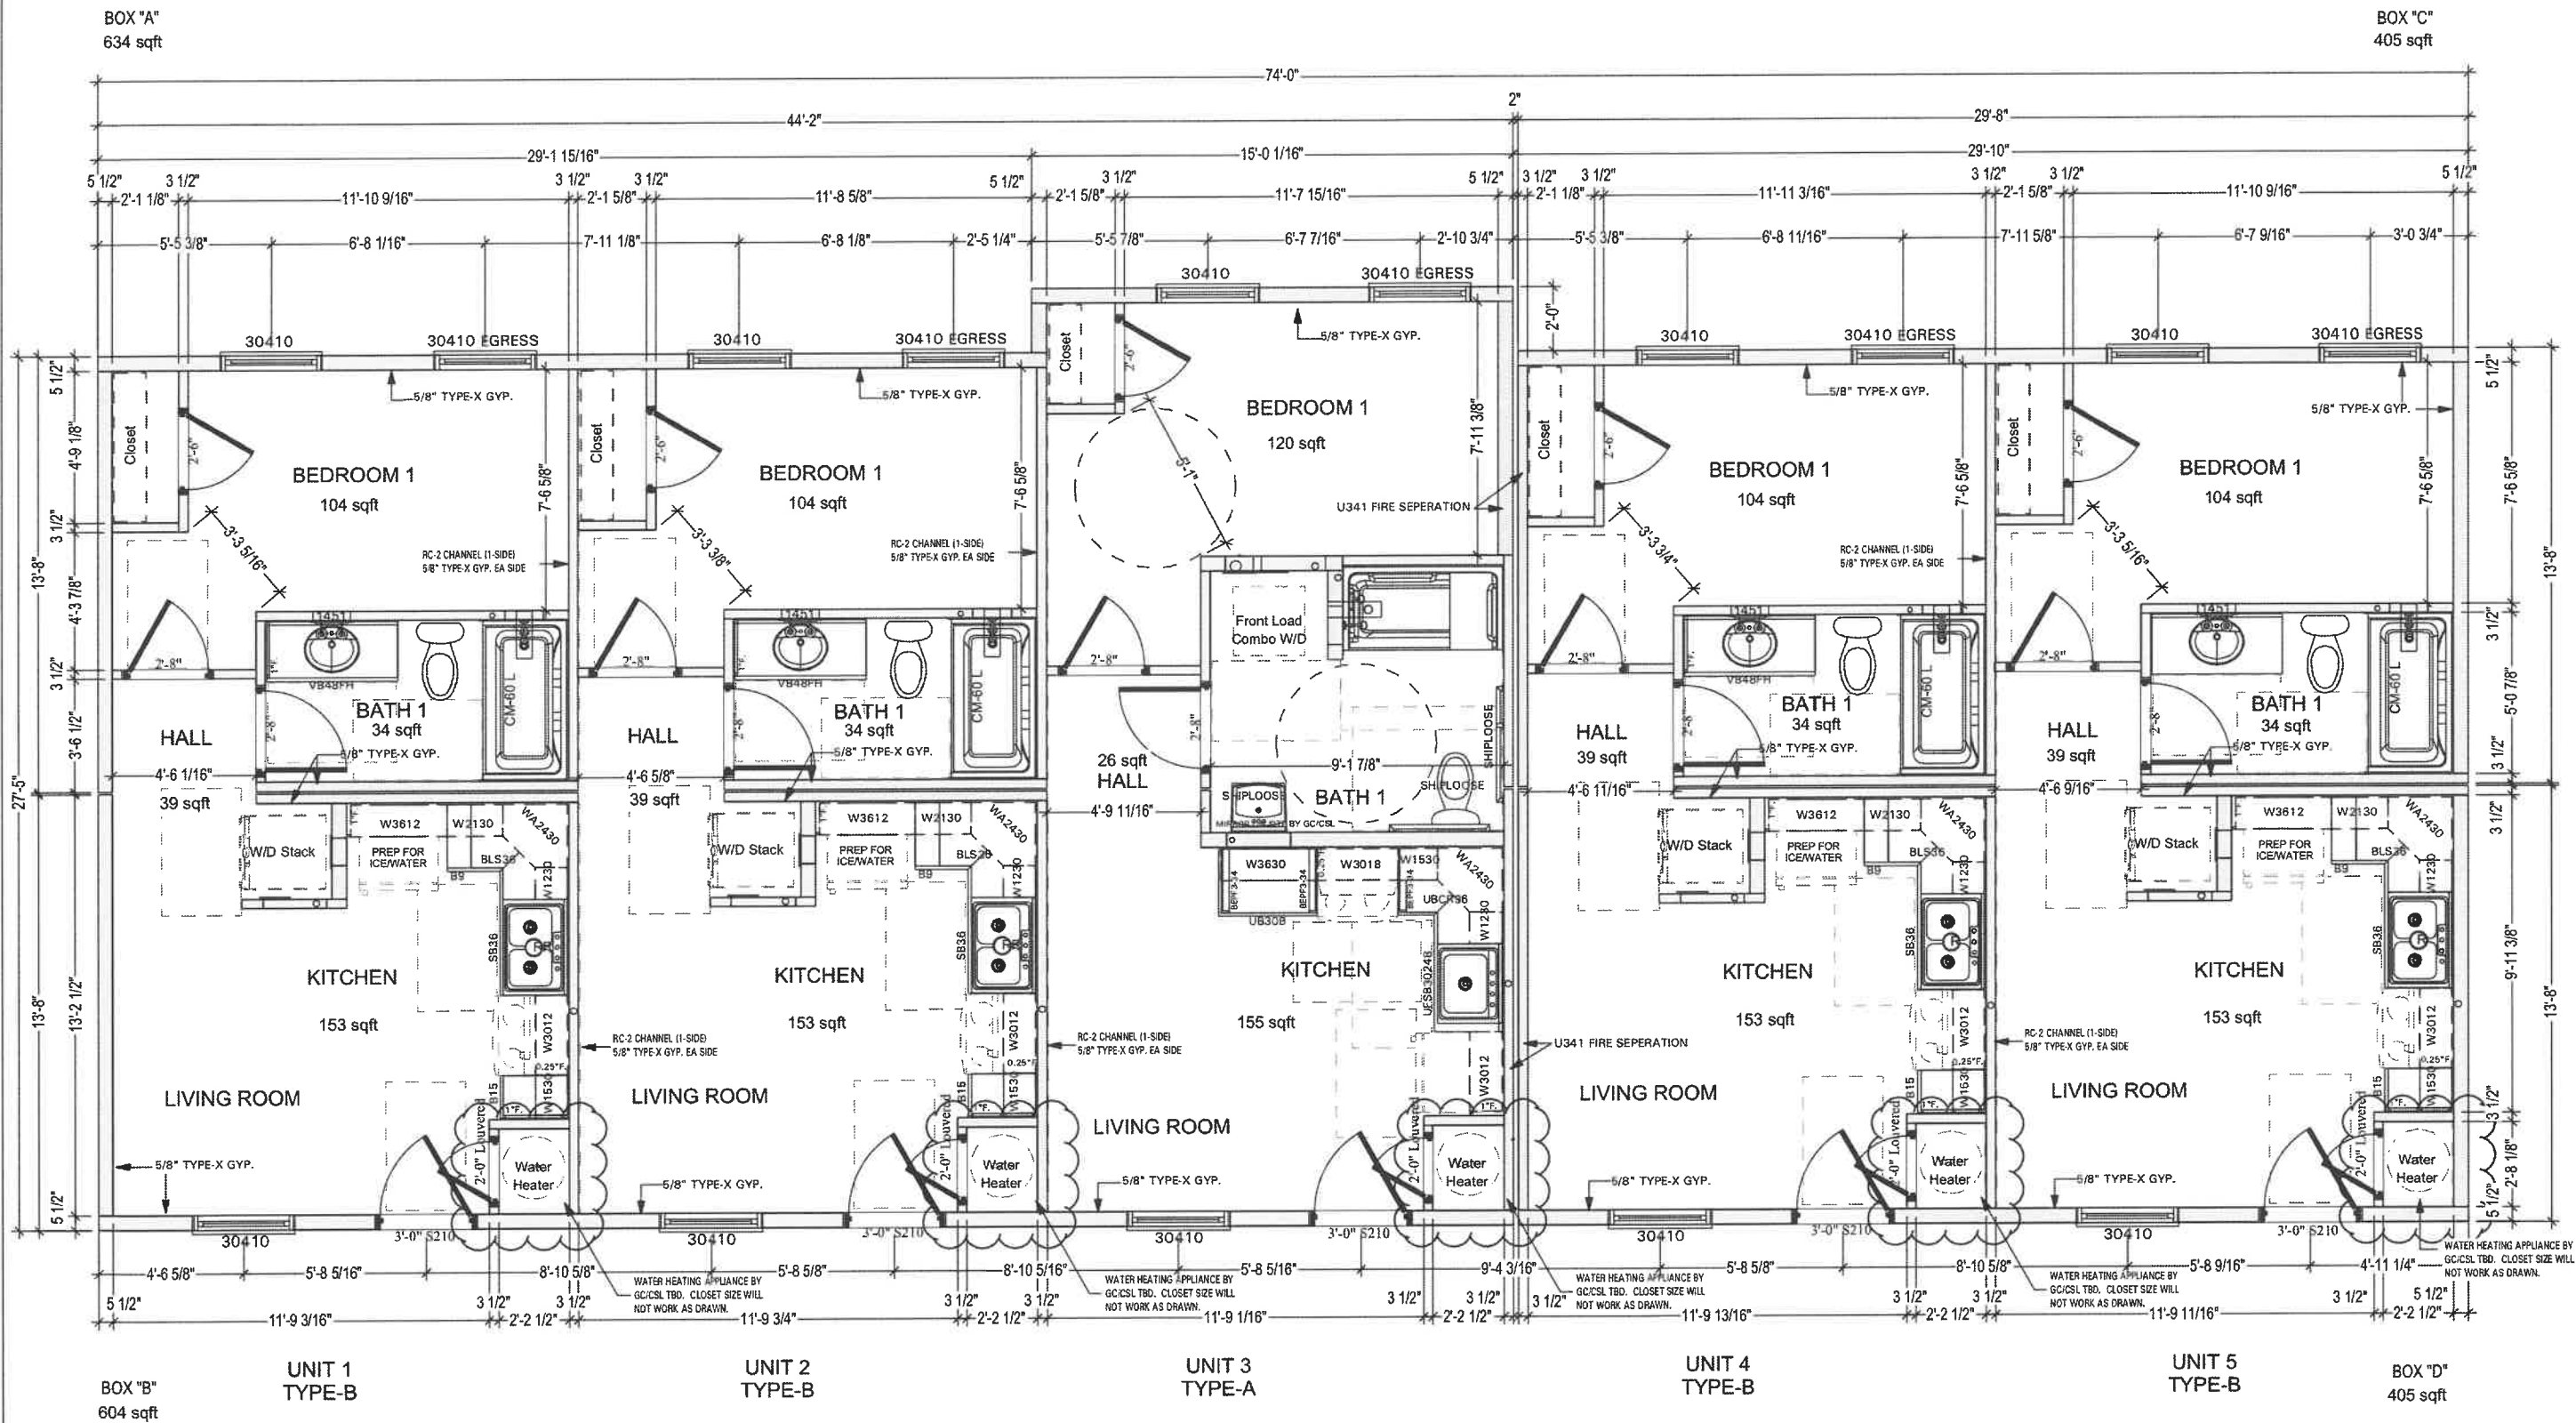

OPERABLE PARTS: TYPE-A
CONTROLS, SWITCHES, RECEPTICALS, HVAC/T-STATS, APPLIANCE CONTROLS,
OPERATING HW HINDOWS, PLUMBING FIXTURE CONTROLS, SECURITY SYSTEM
CONTROLS, INTERCOMS, ECT. MUST COMPLY WITH SECTION 309 & 1003.9

KBS Builders Inc.
CUSTOM... QUALITY...
300 PARK STREET
SOUTH PARIS, ME 04281
PHONE: 207-739-2400
FAX: 207-739-2223
www.kbsbuildersinc.com





BUILDER: Northern Constructors
JOB NAME: 1 Bedrm Building Type
24 Smith Corner Rd
Newton, NH 03858
PERMIT REV#
DATE:

NOTES:
Ranch
50# GSL / 122 MPH (Vult) WIND
HARVEY WINDOWS
8'-0" CLG HGT

FILE: Q-22-0015-JM
SHEET # P4
SCALE: 3/16" = 1'-0"

UNIT #'s 1, 2, 4 & 5
TYPE-B KITCHEN DETAILS

SCALE: 3/8"=1'-0"

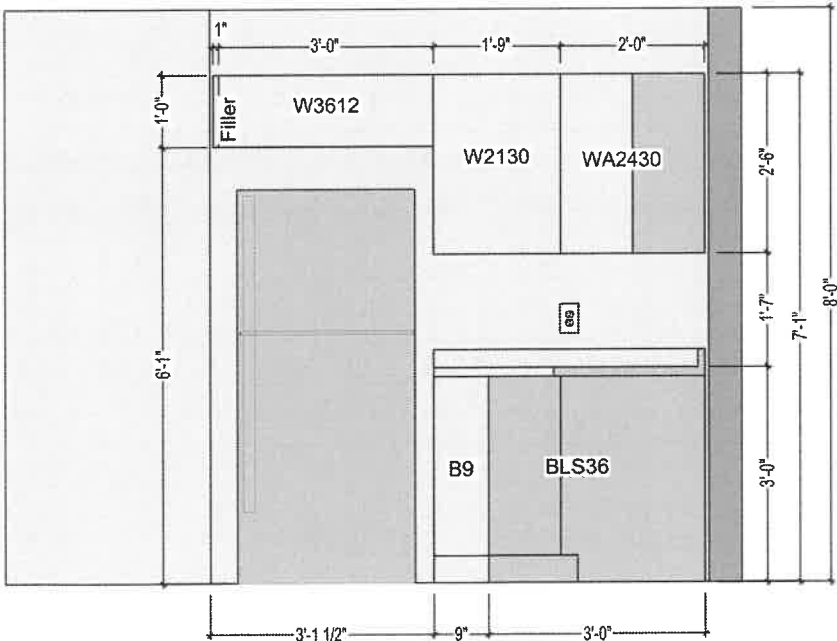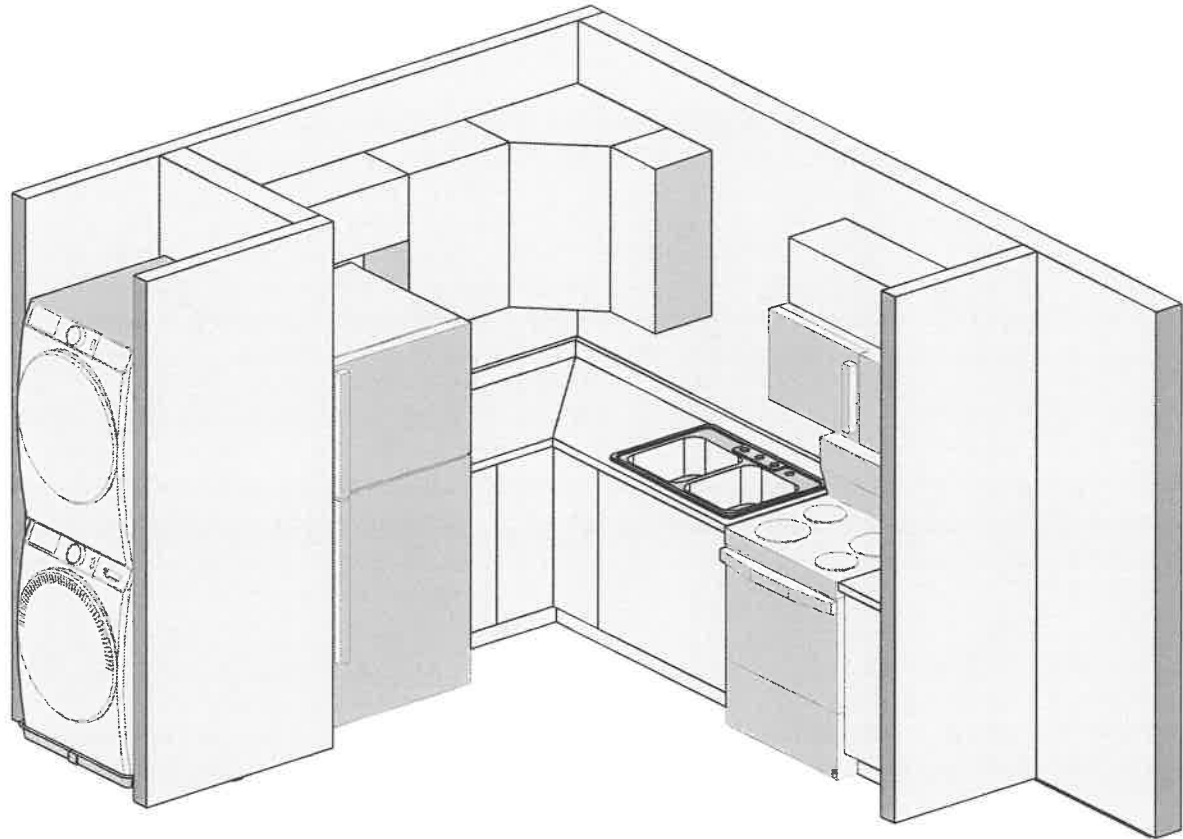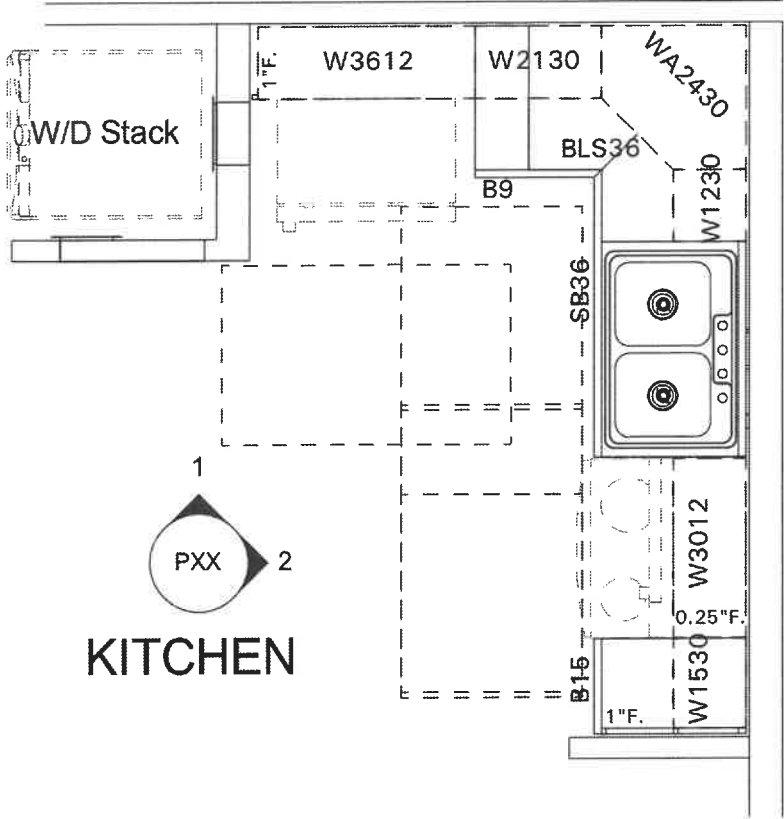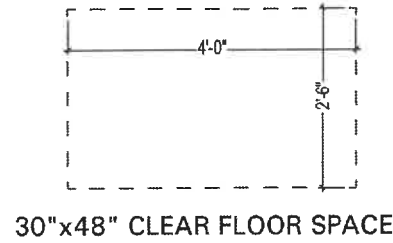


1
**TYPE-B
KITCHEN ELEVATION**
SCALE: 3/8"=1'-0"



2
**TYPE-B
KITCHEN ELEVATION**
SCALE: 3/8"=1'-0"

THE MAX HIGH REACH IS REDUCED TO 46"
WHEN THE REACH OVER AN OBSTRUCTION
IS DEEPER THAN 10" (TO A MAX OF 24")
OBSTRUCTIONS AT SIDE REACHES ARE
LIMITED TO A HEIGHT OF 34"

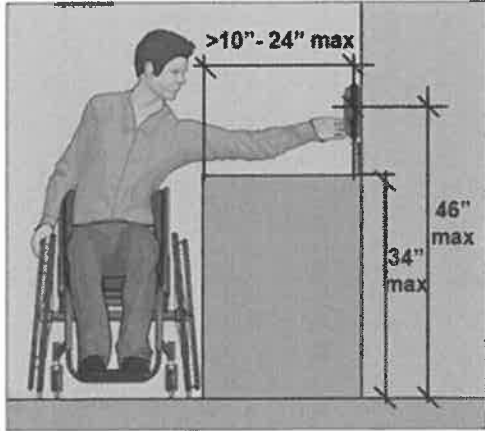

STADARD COUNTER HEIGHT = 36"
STANDARD COUTER DEPTH IS 25 1/4"



Builder:
Northern Constructors
24 Smith Corner Rd
Newton, NH 03858

Job Name:
1 Bedrm Building Type
Puzzle Lane
Newton, NH 03858

Notes:
Ranch
50# GSL / 122 MPH (Vuit) WIND
HARVEY WINDOWS
8'-0" CLG HGT





File: Q-22-0015-JM
Serial #: KBS-
Date: 2/25/2022
Dwn By: SLP

Sheet #
P39

Scale: NONE


UNIT-3
TYPE-A KITCHEN DETAILS

SCALE: 3/8"=1'-0"

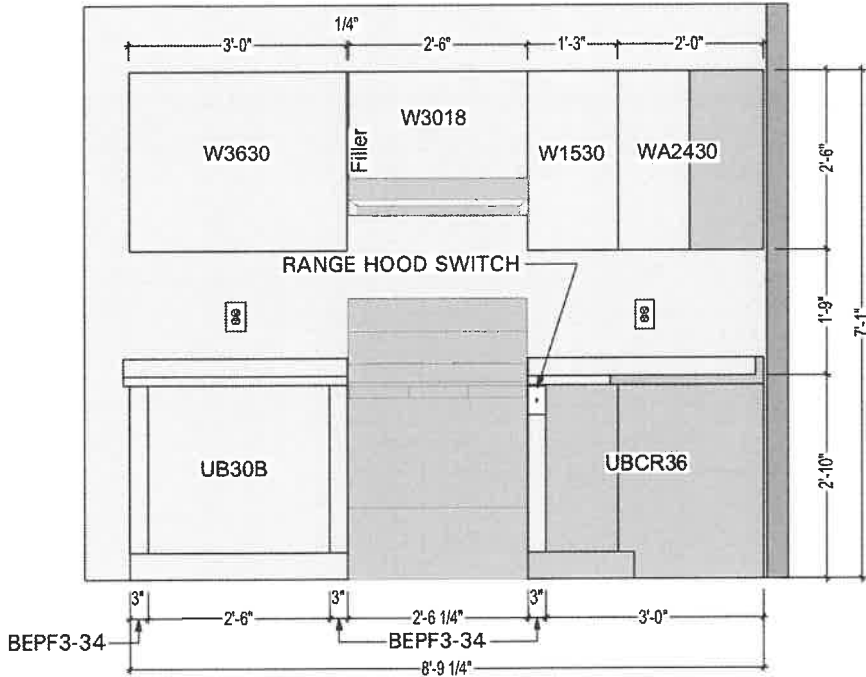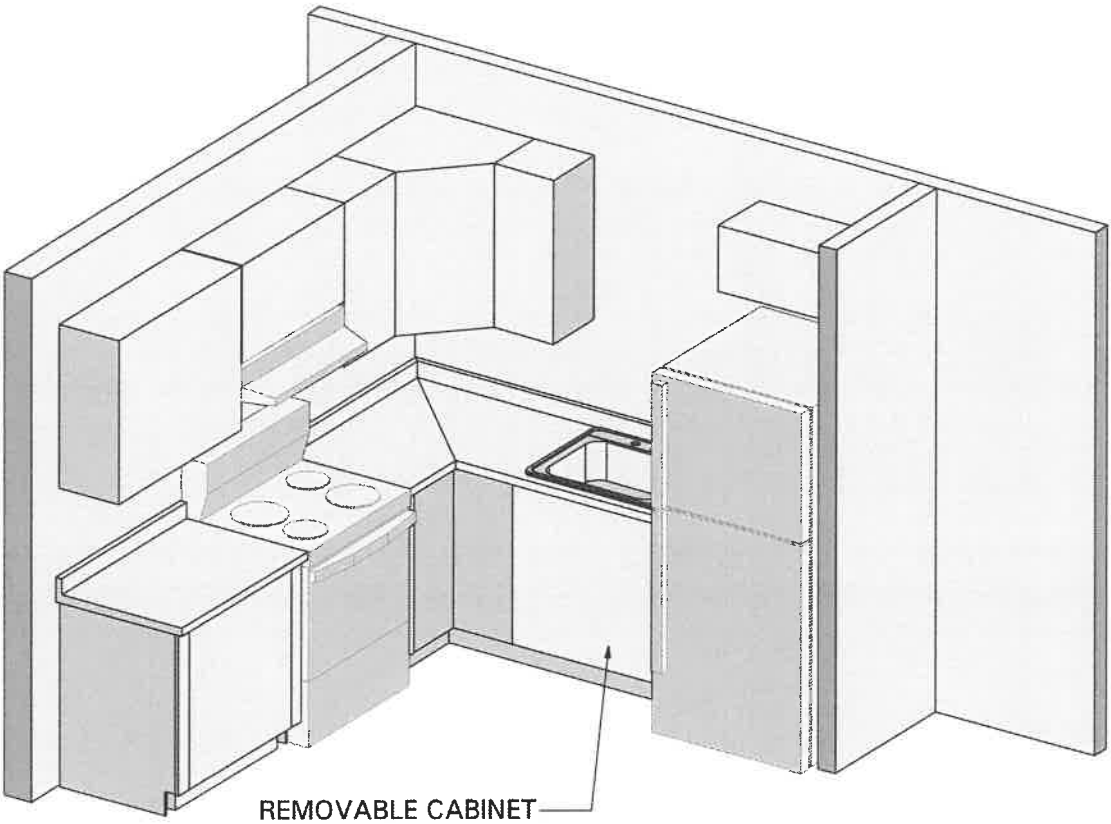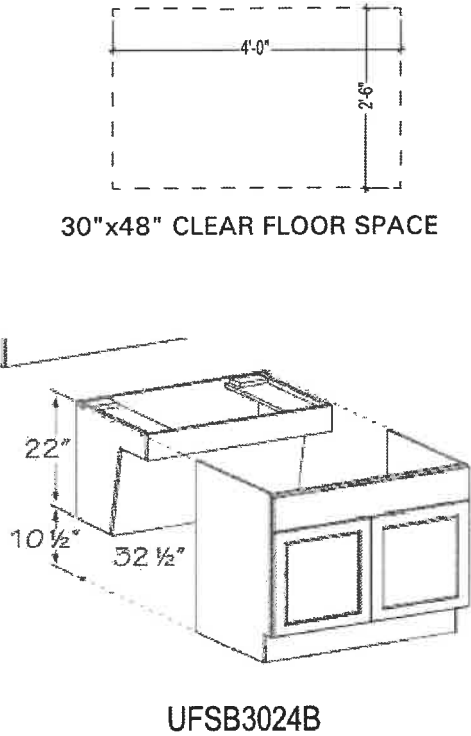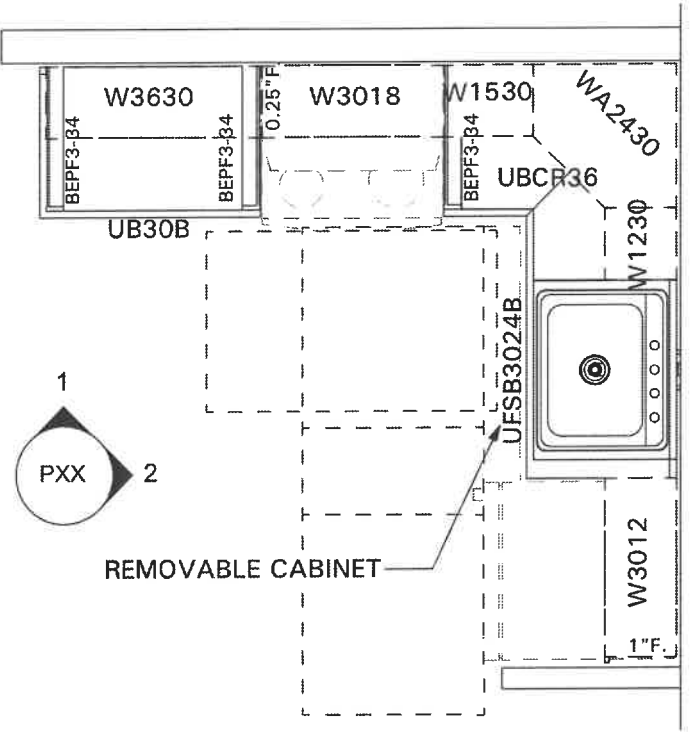

1st FLR TYPE-A
KITCHEN ELEVATION

SCALE: 3/8"=1'-0"

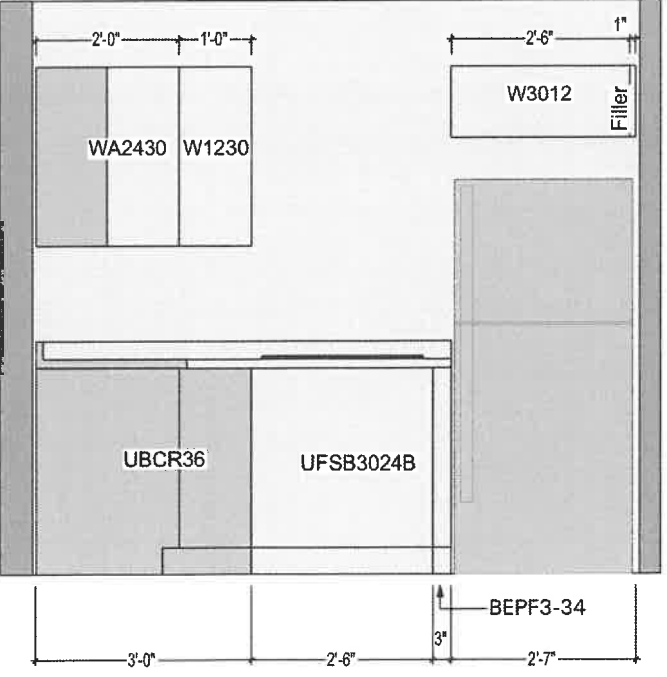

1st FLR TYPE-A
KITCHEN ELEVATION

SCALE: 3/8"=1'-0"

KBS Builders Inc.
CUSTOM... QUALITY...
300 PARK STREET
SOUTH PARIS, ME 04281
PHONE: 207-739-2400
FAX: 207-739-2223
www.kbsbuildersinc.com

Builder: Northern Constructors
24 Smith Corner Rd
Newton, NH 03858

Job Name: 1 Bedrm Building Type
Puzzle Lane
Newton, NH 03858

Rev# / Date:
REV# / DATE: _____
REV# / DATE: _____
REV# / DATE: _____


Notes: Ranch
50# GSL / 122 MPH (Vuit) WIND
HARVEY WINDOWS
8'-0" CLG HGT

File: Q-22-0015-JM
Serial #: KBS-
Date: 2/25/2022
Dwn By: SLP


Details

Sheet #: P40


Scale: NONE

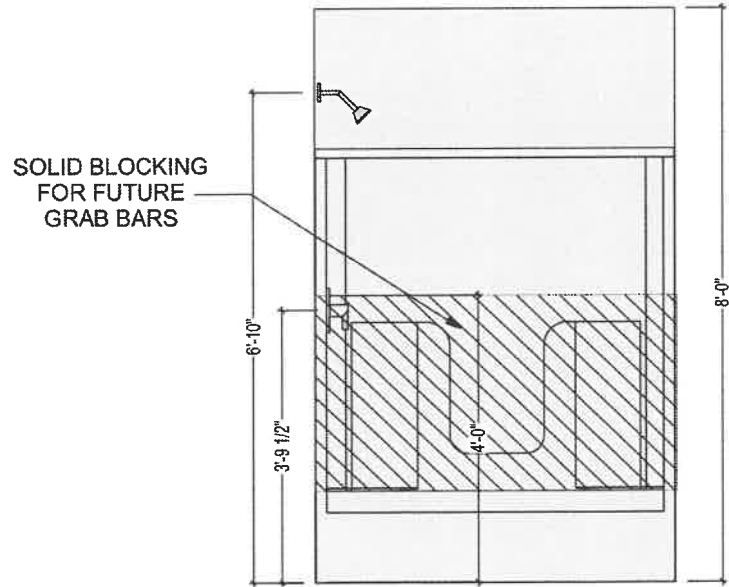


1 **TYPE-B
BATH DETAILS**
SCALE: 3/8"=1'-0"

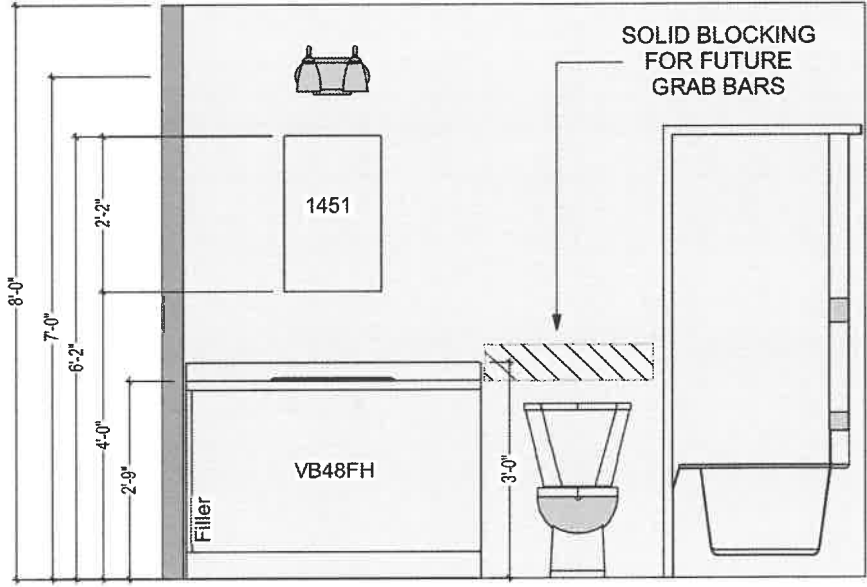


2 **TYPE-B
BATH DETAILS**
SCALE: 3/8"=1'-0"

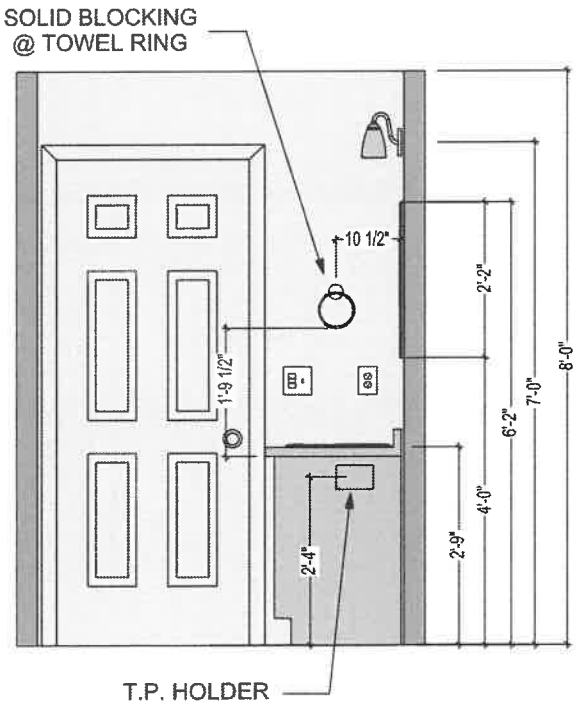

3 **TYPE-B
BATH DETAILS**
SCALE: 3/8"=1'-0"

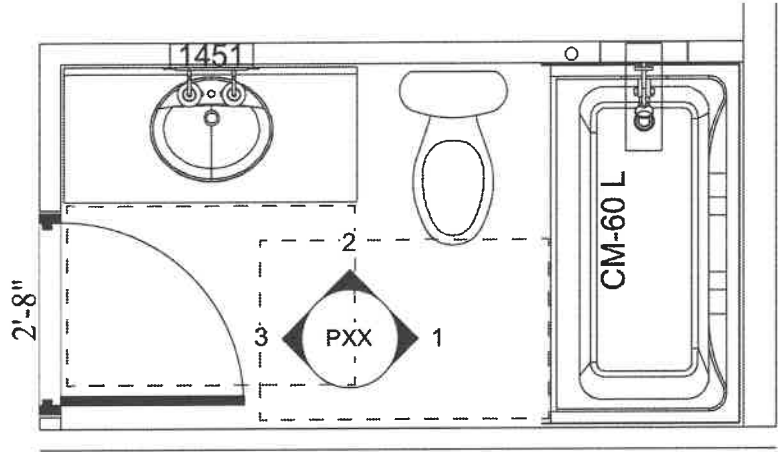


**UNIT #'s 1, 2, 4 & 5
TYPE-B BATH DETAILS**
SCALE: 3/8"=1'-0"

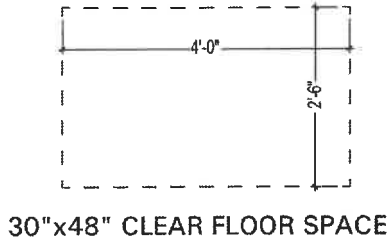


 KBS Builders Inc. CUSTOM... QUALITY... 300 PARK STREET SOUTH PARIS, ME 04281 PHONE: 207-739-2400 FAX: 207-739-2223 www.kbsbuildersinc.com	
BUILDER: Northern Constructors 24 Smith Corner Rd Newton, NH 03858	PERMIT REV# DATE:
JOB NAME 1 Bedrm Building Type Puzzle Lane Newton, NH 03858	REV# DATE:
NOTES: Ranch 50# GSL / 122 MPH (Vuit) WIND HARVEY WINDOWS 8'-0" CLG HGT	DETAILS
FILE: Q-22-0015-JM SERIAL #: KBS- DATE: 2/25/2022 DWN BY: SLP	SCALE: NONE

UNIT #'s 3
TYPE-B BATH DETAILS





SCALE: 3/8"=1'-0"

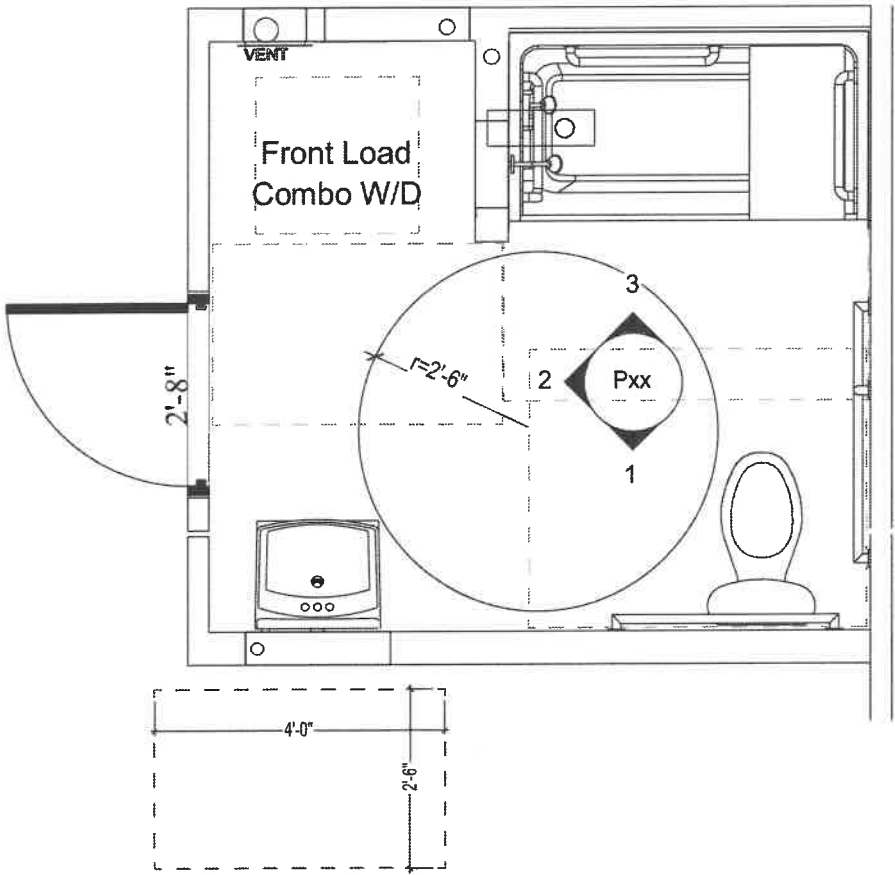

30"x48" CLEAR FLOOR SPACE

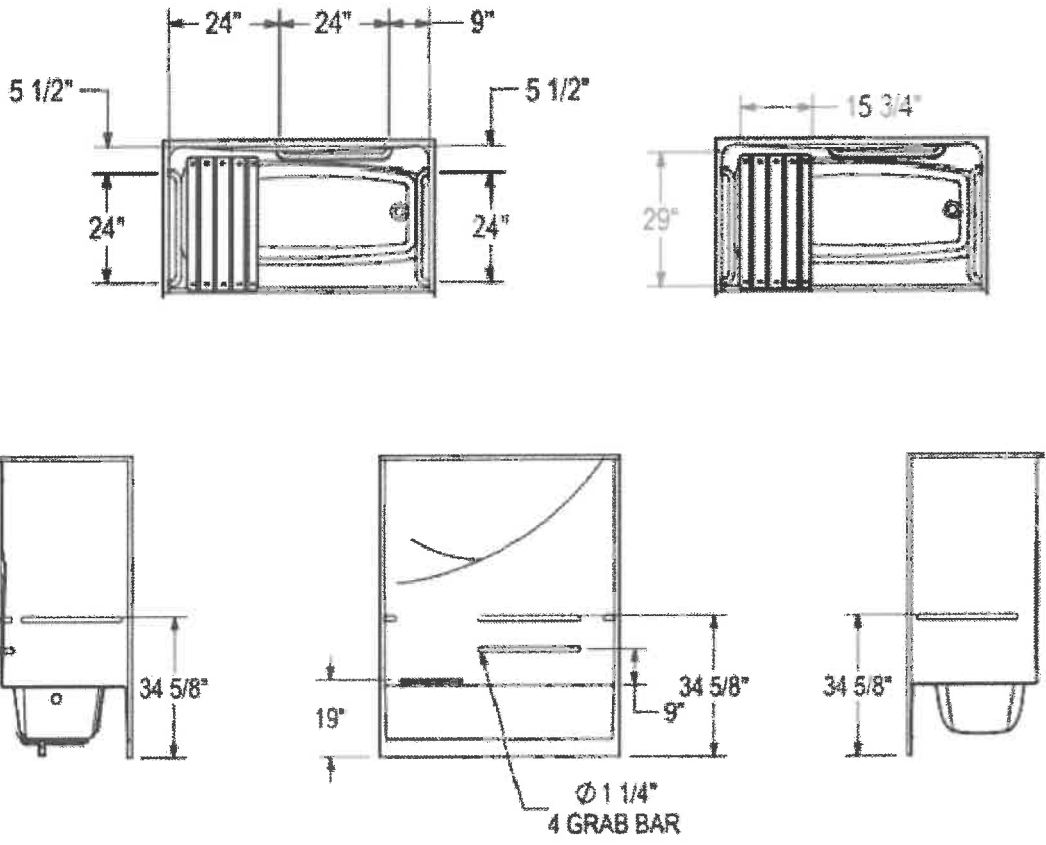

American Standard Faucet # 1662SG.215.002
Hand Held Shower and 36" Slider/Grab Bar
** Include Standard Shower Head **

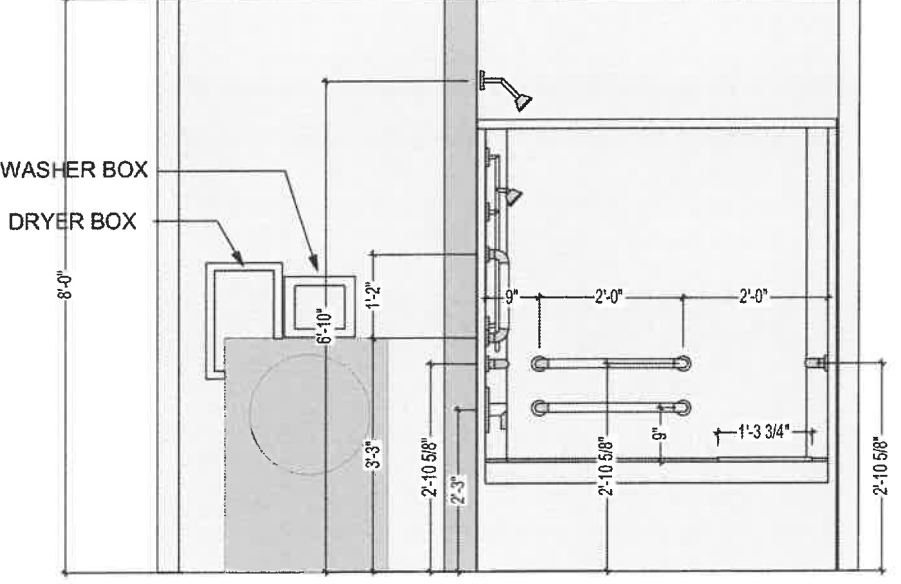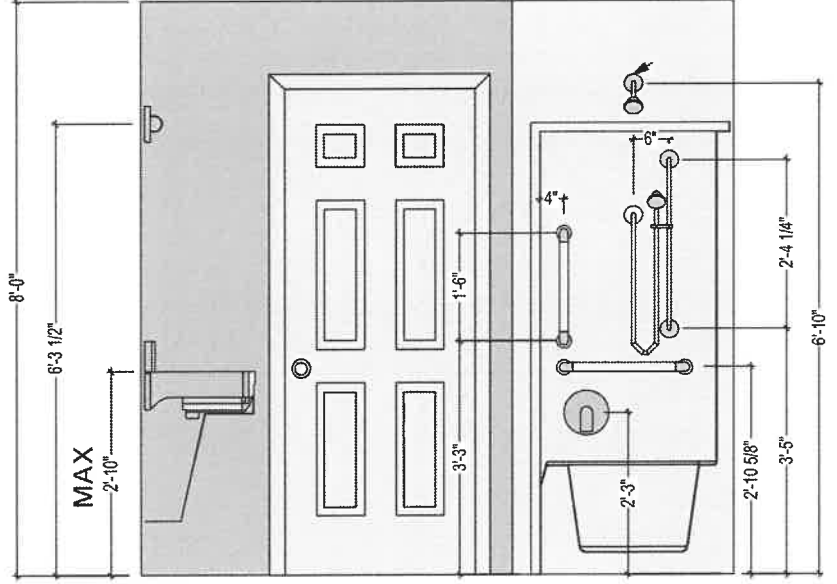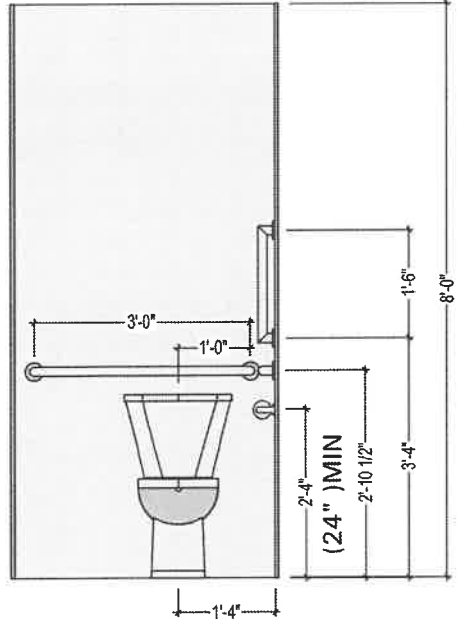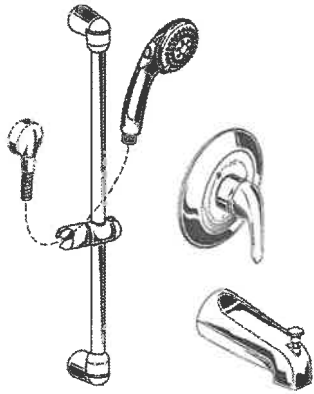

1 TYPE-A
BATH DETAILS
SCALE: 3/8"=1'-0"

2 TYPE-A
BATH DETAILS
SCALE: 3/8"=1'-0"

3 TYPE-A
BATH DETAILS
SCALE: 3/8"=1'-0"

KBS Builders Inc.
CUSTOM... QUALITY...
300 PARK STREET
SOUTH PARIS, ME 04281
PHONE: 207-739-2400
FAX: 207-739-2223
www.kbsbuildersinc.com

BUILDER: Northern Constructors
24 Smith Corner Rd
Newton, NH 03858

JOB NAME: 1 Bedrm Building Type
Puzzle Lane
Newton, NH 03858

REV# **DATE** **PERMIT REV#**
REV#1: 2/25/2022
REV#2: 2/25/2022
REV#3: 2/25/2022
REV#4: 2/25/2022

NOTES:
Ranch
50# GSL / 122 MPH (Vuit) WIND
HARVEY WINDOWS
8'-0" CLG HGT

FILE: Q-22-0015-JM
SERIAL #: KBS-
DATE: 2/25/2022
OWN BY: SLP

DETAILS

SHEET #
P1007

SCALE: NONE